



NORTH WEST ELEVATION
1:100 A1
1:200 A3

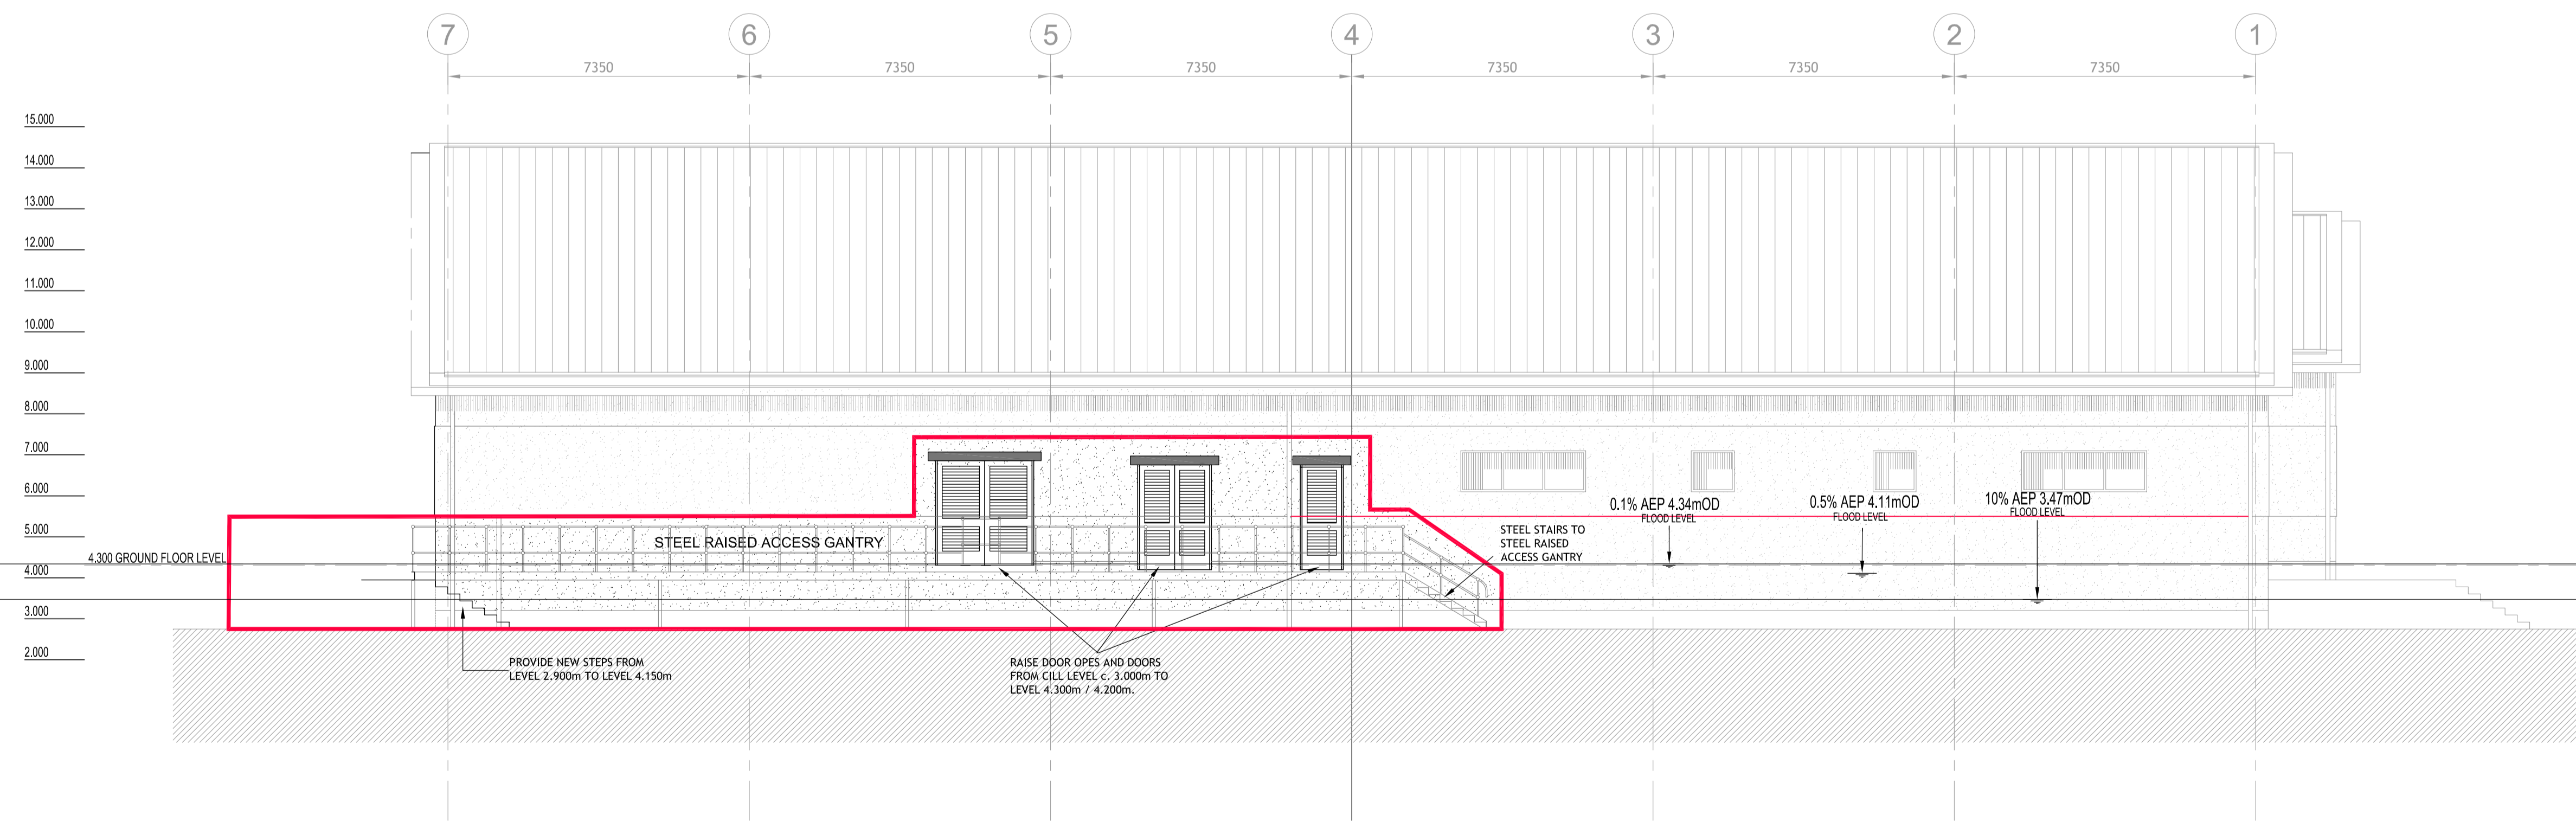

SOUTH WEST ELEVATION
1:100 A1
1:200 A3

© PUNCH Consulting Engineers

This drawing and any design hereon is the copyright of the Consultants and must not be reproduced without their written consent. All drawings remain the property of the Consultants. Figured dimension only to be taken from this drawing. Consultants to be informed immediately of any discrepancies before work proceeds.

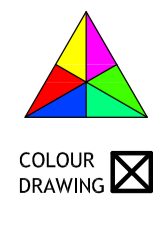

Date Drawn: 18-09-2020
Drawn By: J.Cooke
Date Issued: 18-09-2020
Issued By: R. Tackaberry



Rev	Amendment	By	Date

Client:
Comhairle Cathrach & Contae Lúimnigh
Limerick City & County Council

Job: ASKEATON POOL FLOOD PROTECTION WORKS
Title: PROPOSED ELEVATIONS
PUNCH consulting engineers
Dublin|Limerick|Cork|Galway|Glasgow
Carnegie House, Library Road, Dun Laoghaire, Co. Dublin, A96 C7W7
IRL: +353 1 271 2200 www.punchconsulting.com

Stage: Planning
Scale @ A1: 1:100
Technician Check: J. Daly
Engineer Check: R. Tackaberry
Approved: R. Tackaberry
Drawing No: 201-168-112
Rev: PL01