


TYPICAL DETAILS OF ATTENUATION TANK USING PLUVIAL CUBE MODULE UNITS WITH STONE TRENCH

Product shown is indicative only. Exact product/details etc. will be developed at detailed design.

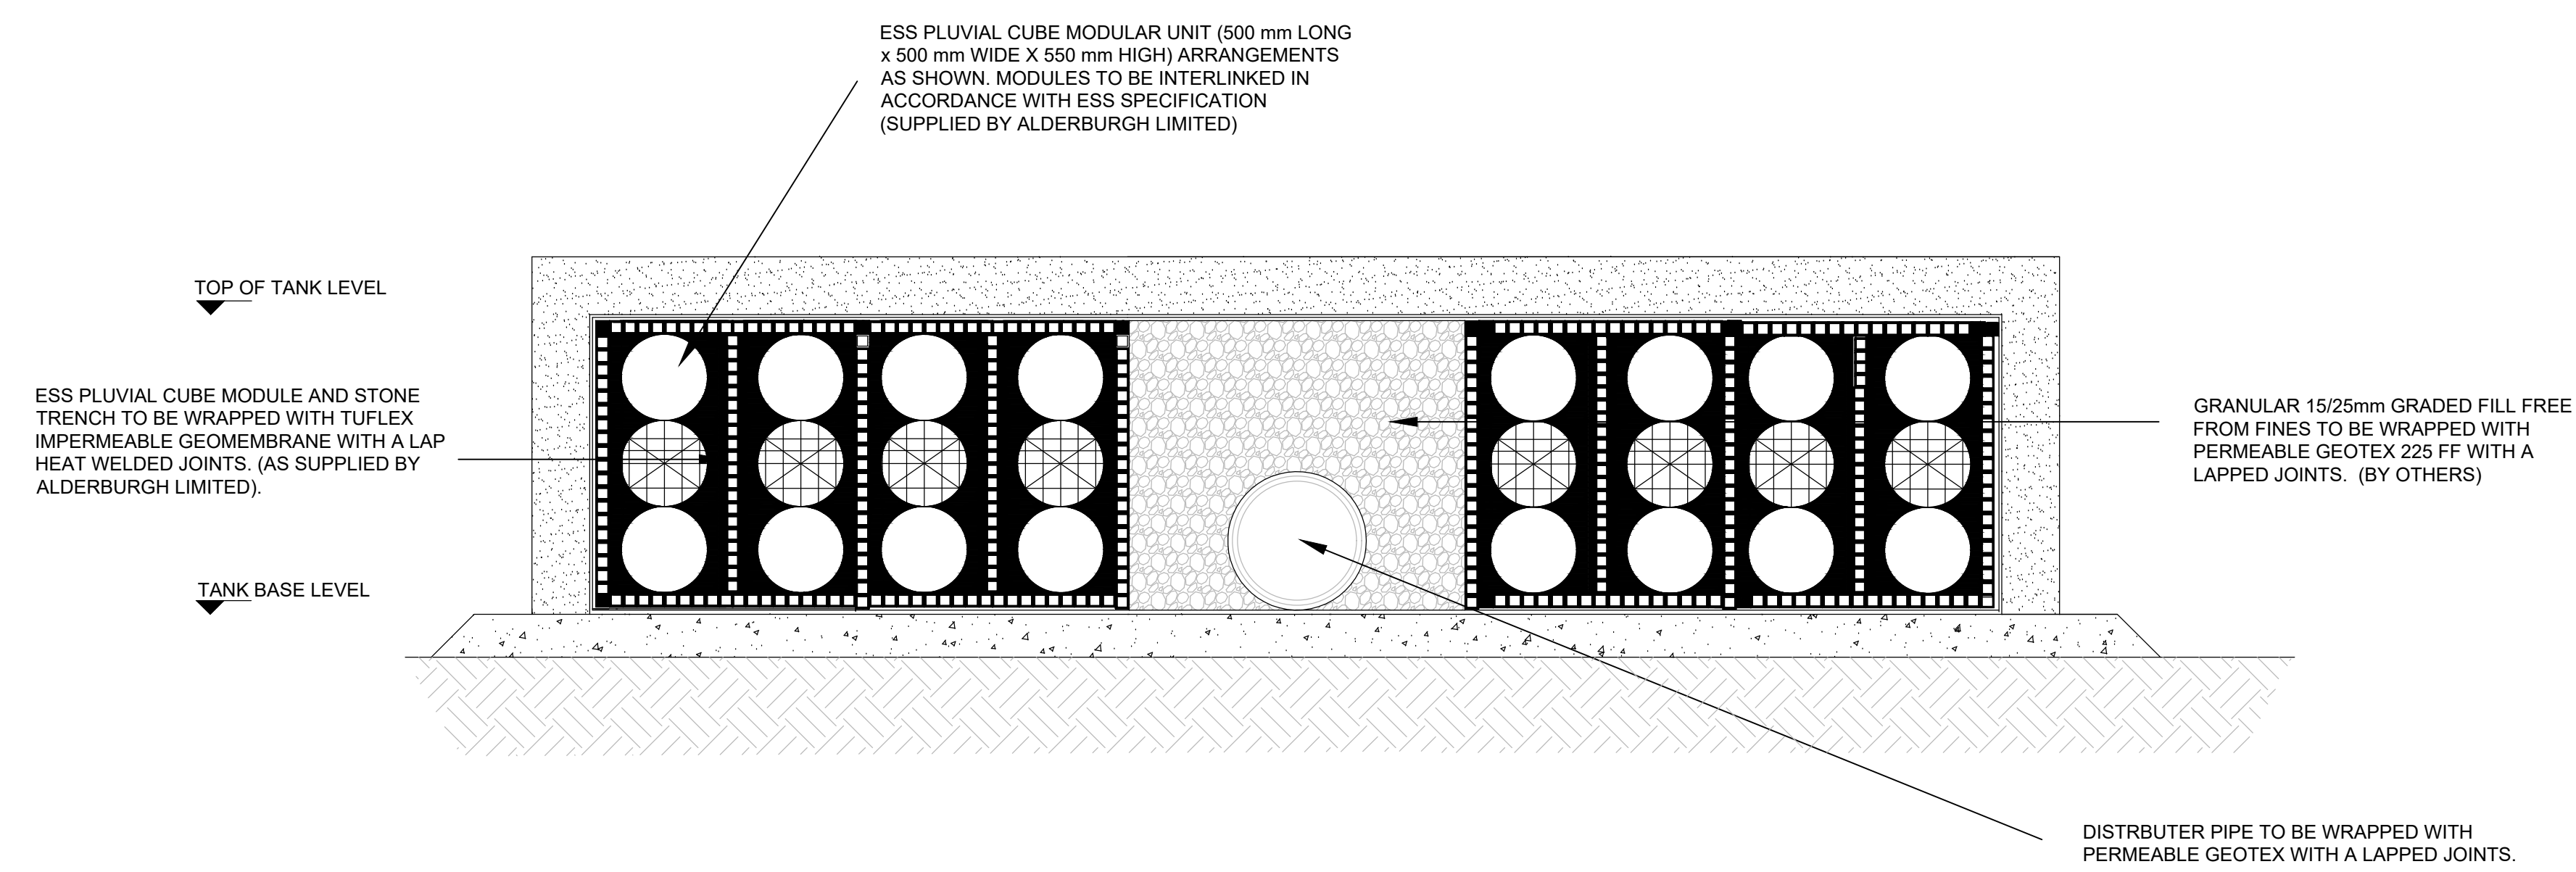

TYPICAL DETAILS OF ATTENUATION TANK USING PLUVIAL CUBE MODULAR UNITS WITH STONE TRENCH SECTION A-A

- Notes:**
- This Drawing shall be Read in Conjunction with all Other Relevant Specifications & Drawings.
 - All Dimensions in Millimeters (mm) unless noted otherwise.
 - Refer to MUN-ARUP-ZZ-ZZ-DR-C-0020 for the Proposed Surface Water Drainage Layout.

Rev	Date	By	Chkd	Appd
P01	15/12/23	WC	AN	KG

ARUP

Arup, Harrogate House,
Upper Harrogate Street, Limerick
Tel: +353 (0)11 211700
www.arup.com

Client
Limerick City & County Council

Project Title
**Mungret Residential Development,
Mungret, Limerick**

Drawing Title
**Proposed Surface Water Attenuation
and SuDS Details**

Scale at A0	As Shown
Role	Civil Infrastructure
Suitability	S2 - Suitable for Information
Arup Job No	261585-00
Rev	P01
Name	MUN-ARUP-ZZ-ZZ-DR-C-0101